


FOR CONTINUATION
SEE SHEET 2

FOR CONTINUATION
SEE SHEET 2

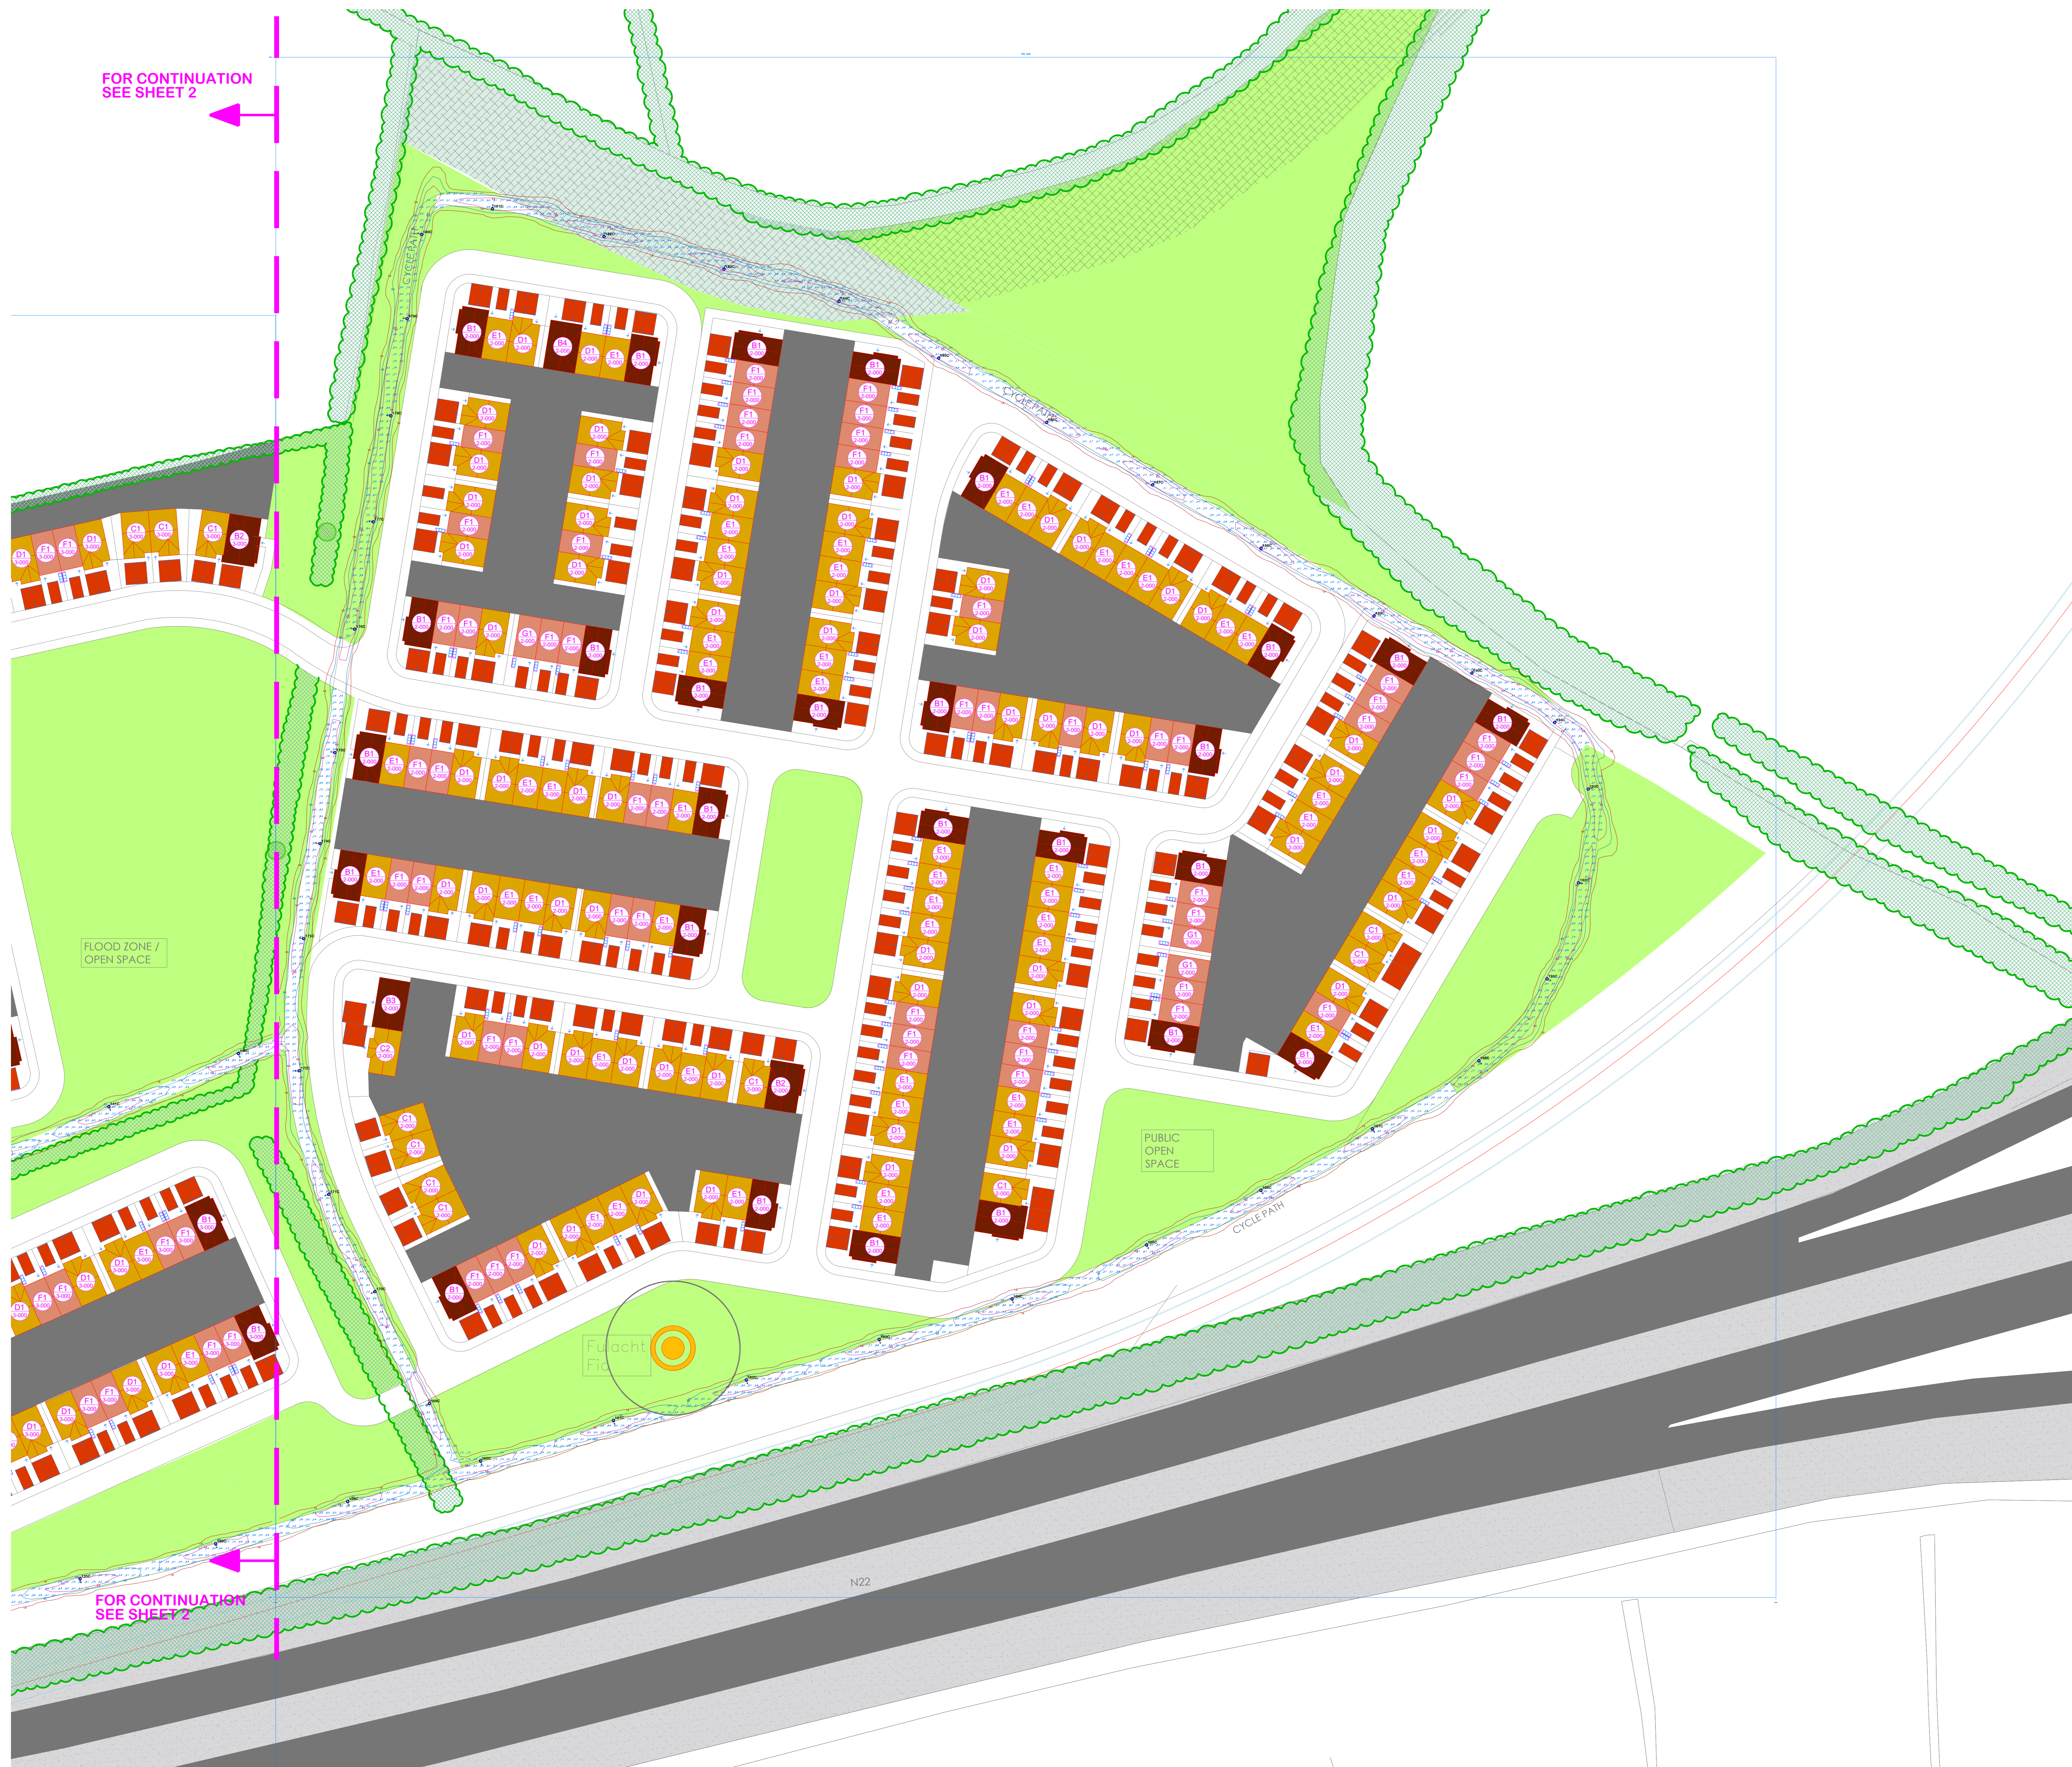

GENERAL NOTES

1. ALL DIMENSIONS ARE GIVEN IN MILLIMETERS UNLESS OTHERWISE INDICATED.
2. THIS DRAWING IS TO BE READ IN CONJUNCTION WITH THE SCOPE OF WORKS. ANY DISCREPANCIES ARE TO BE BROUGHT TO THE ATTENTION OF KELLIHERS FOR CLARIFICATION PRIOR TO ANY WORK COMMENCING.
3. CONTRACTOR TO FIELD VERIFY ALL DIMENSIONS, DISCREPANCIES ARE TO BE NOTIFIED TO THE CONTRACTOR AND DESIGN FOR RESOLUTION.
4. ALL WORKS TO COMPLY WITH PREVIOUSLY AGREED AND ISSUED SPECIFICATIONS

LEGEND


<p>Site west Results - Horizontal Illuminance (lux) Eavg= 6.50 Emin= 1.26 Emax= 41.12 Emin/Eavg= 0.03 Emin/Emax= 0.19 Eavg/Emin= 6.33</p>	<p>Spine road west 2 Results - Horizontal Illuminance (lux) Eavg= 10.22 Emin= 2.45 Emax= 17.33 Emin/Eavg= 0.14 Emin/Emax= 0.24 Eavg/Emin= 1.70</p>
<p>Site center Results - Horizontal Illuminance (lux) Eavg= 9.09 Emin= 1.20 Emax= 10.83 Emin/Eavg= 0.11 Emin/Emax= 0.24 Eavg/Emin= 2.13</p>	<p>Spine road east Results - Horizontal Illuminance (lux) Eavg= 10.63 Emin= 2.06 Emax= 18.01 Emin/Eavg= 0.11 Emin/Emax= 0.21 Eavg/Emin= 1.80</p>
<p>Site east Results - Horizontal Illuminance (lux) Eavg= 9.16 Emin= 1.04 Emax= 9.85 Emin/Eavg= 0.11 Emin/Emax= 0.20 Eavg/Emin= 1.31</p>	<p>Link road 1 Results - Horizontal Illuminance (lux) Eavg= 10.63 Emin= 3.31 Emax= 24.90 Emin/Eavg= 0.13 Emin/Emax= 0.31 Eavg/Emin= 2.30</p>
<p>Spine road west 1 Results - Horizontal Illuminance (lux) Eavg= 11.35 Emin= 4.13 Emax= 21.41 Emin/Eavg= 0.19 Emin/Emax= 0.36 Eavg/Emin= 1.88</p>	<p>Link road 2 Results - Horizontal Illuminance (lux) Eavg= 10.88 Emin= 3.25 Emax= 17.21 Emin/Eavg= 0.19 Emin/Emax= 0.30 Eavg/Emin= 1.56</p>

Luminaire Data

Luminaire A BGP293 DW50	Lamp LED-HB 5.25 730 MF 0.84
Luminaire B BGP292 DW50	Lamp LED-HB 5.25 730 MF 0.84
Luminaire C BGP291 DRXN1	Lamp LED-HB 5.25 730 MF 0.80
Luminaire D BGP291 DRM1	Lamp LED-HB 5.25 730 MF 0.80

- Key
- Luminaire A Column
 - Luminaire B Column
 - Luminaire C Column
 - Luminaire D Column
 - Beam Aiming Target
 - Photometric Centre

All Dimensions in metres

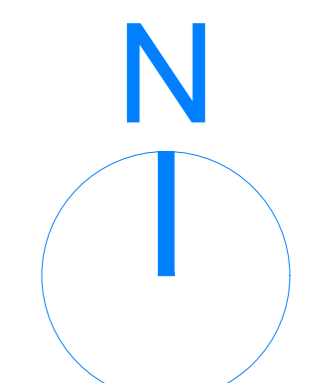

REVISION	DESCRIPTION	DRAWN	CHECKED	APPROVED	DATE
1	LAYOUT REVISED - REISSUED FOR APPROVAL	DMD	PS	PS	11JUN25
2	ISSUED FOR COUNCIL APPROVAL	DMD	PS	PS	15MAY25

THIS DRAWING CONTAINS INFORMATION WHICH IS THE PROPERTY OF KELLIHERS LTD. THIS DRAWING IS RELEASED IN CONFIDENCE AND ITS CONTENTS MAY NOT BE DISCLOSED WITHOUT THE PRIOR WRITTEN CONSENT OF KELLIHERS LIMITED.

APPROVALS		DATE	PROJECT: MAGLIN LANDS	
DESIGNED	DMD	15MAY25	KELLIHERS ELECTRICAL LTD. 1050 BUSINESS PARK, BALLYMOUNT, DUBLIN 12	
CHECKED	DMD	15MAY25		
QUOTED	PS	15MAY25		
APPROVED	DMD	15MAY25	MAGLIN LANDS RESIDENTIAL BALLINCOLLIG CORK CITY SPINE ROADS/WALKWAYS LIGHTING LAYOUT SHEET 3 OF 6	
OWNER	PS	15MAY25		
DATE	15MAY25	FILE NO.	KE/MLB/06	1
BY	PHILIPS	TO FIT	1/500@A0	3 - 6